 



委託場所



県分団車庫

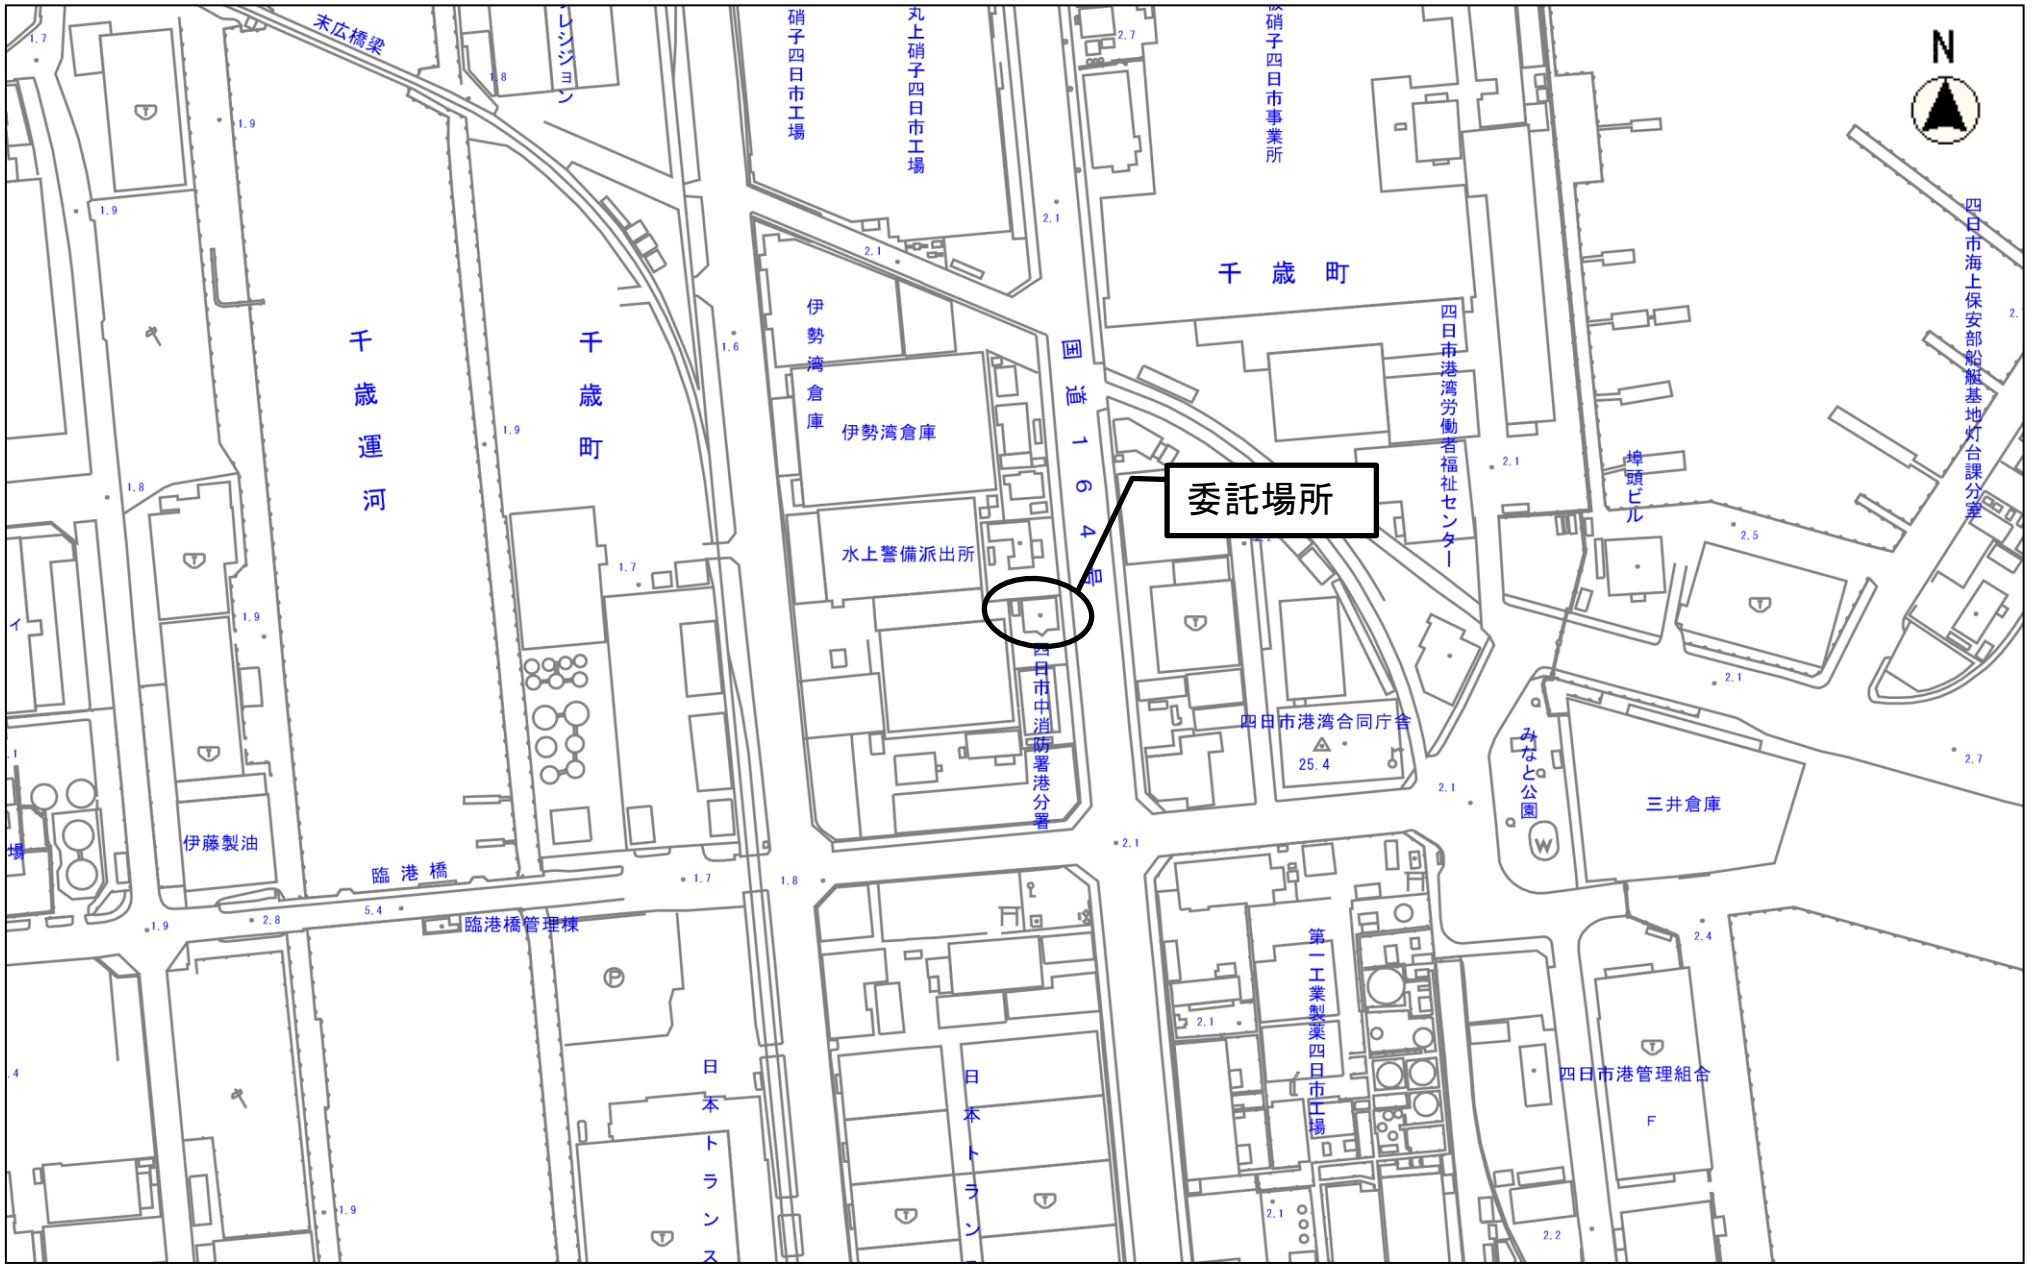



縮尺 1 : 2500  
0 10 20 30 40 50 60 70 80

中消防署港分署



縮尺 1 : 2500  
2015105 0 10 20 30 40 50 60 70 80

 北消防署

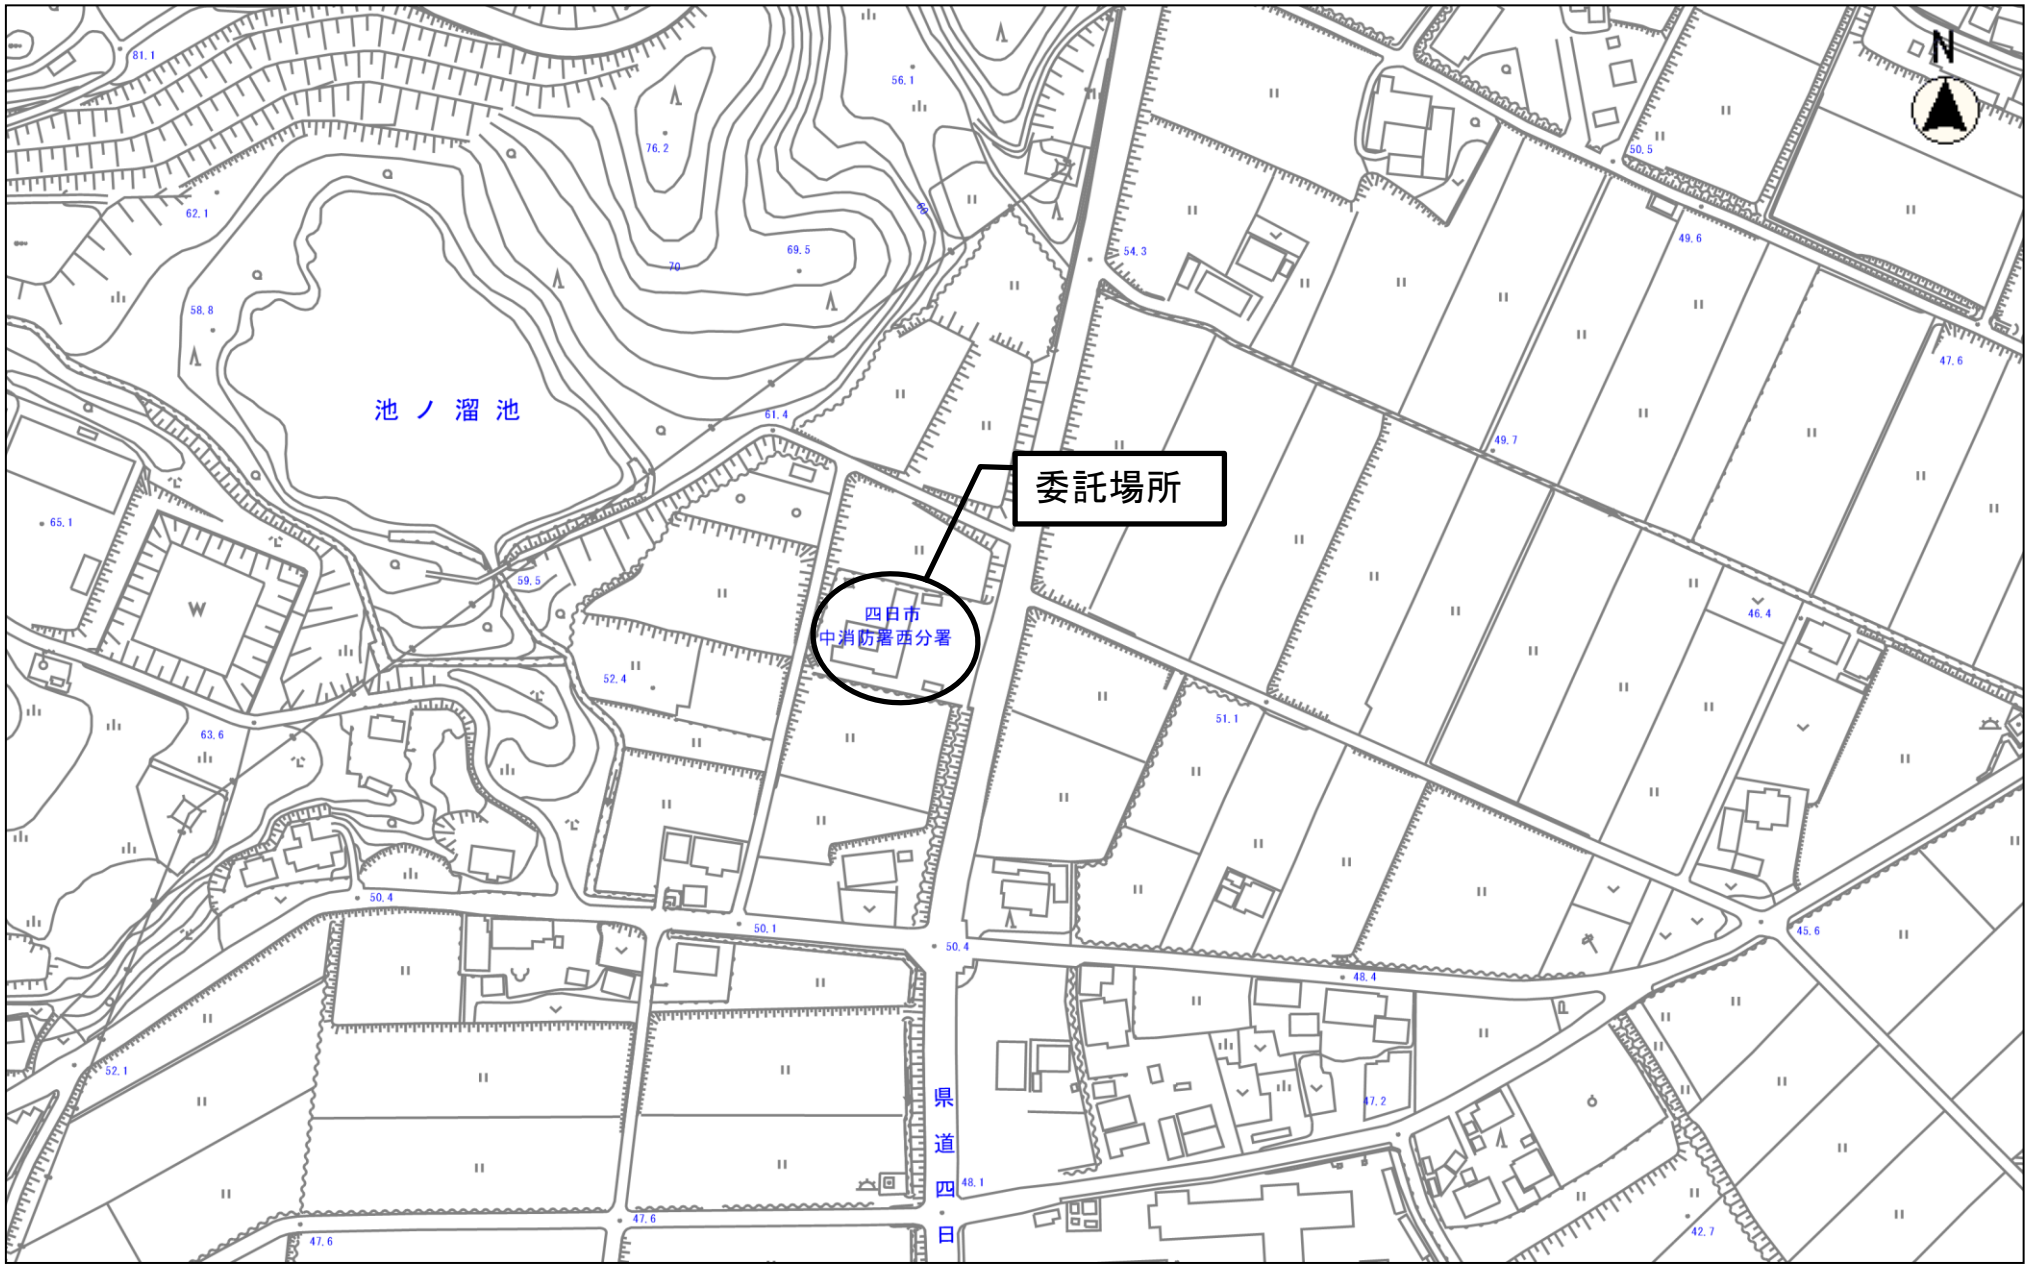

中消防署西分署